

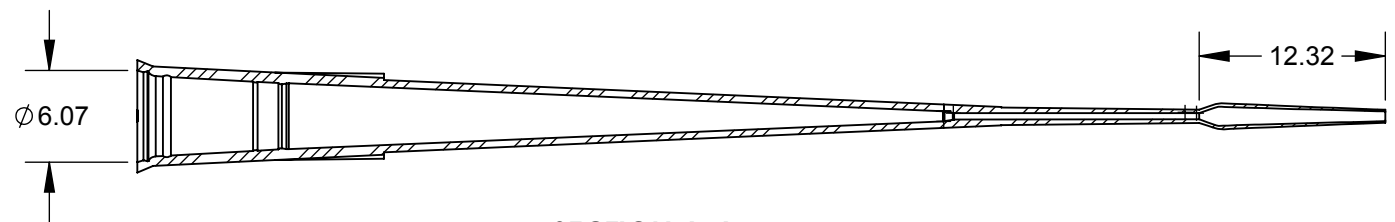
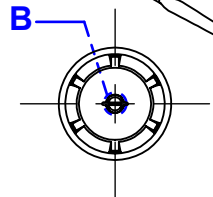
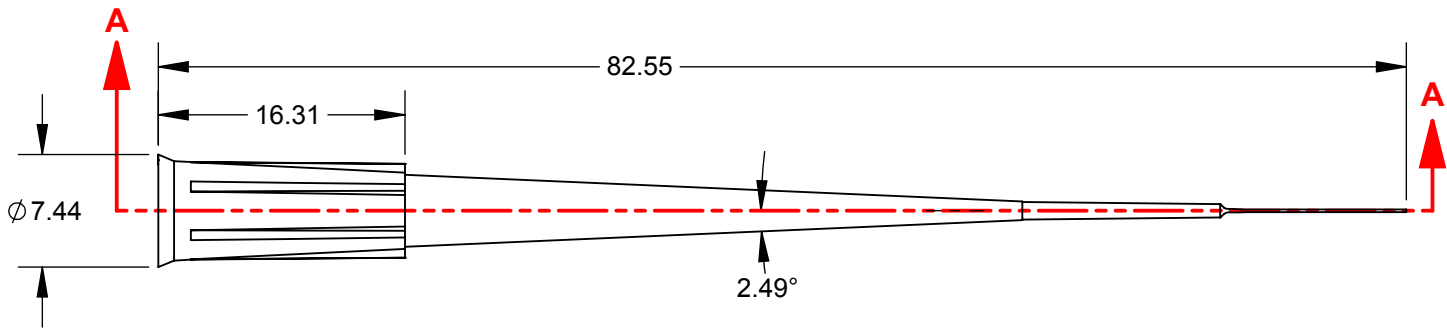



REV.	DESCRIPTION	DATE	DRN BY	APPRD
------	-------------	------	--------	-------

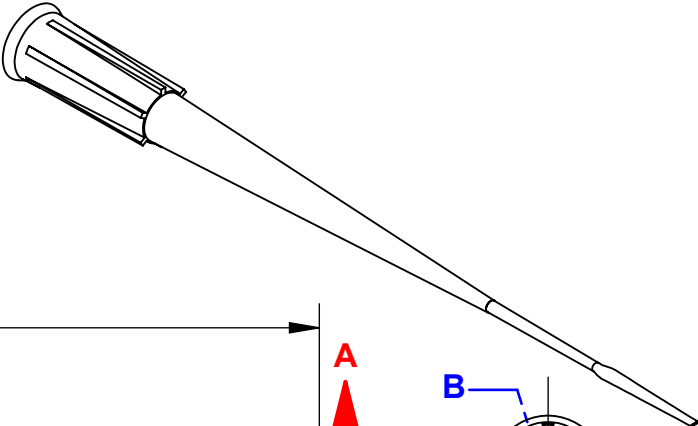

**SECTION A-A  
SCALE: 2 : 1**

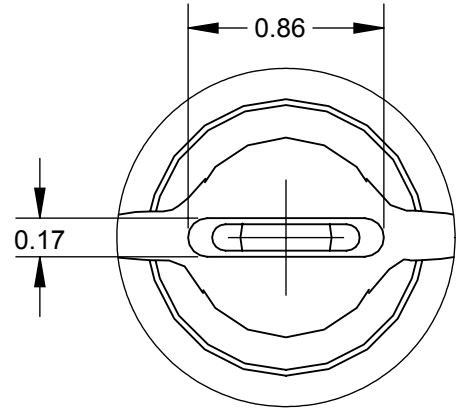

**DETAIL B  
SCALE: 30 : 1**

UNLESS OTHERWISE SPECIFIED DIMENSIONS ARE IN MILLIMETERS		CAD GENERATED DRAWING. DO NOT MANUALLY UPDATE		 <b>1310 Thurman Street</b> <b>Lodi CA, 95240</b> <b>Ph: (209) 333-2120</b> <b>Fx: (209) 333-8623</b> <b>info@scientificspecialties.com</b>
		APPROVALS	DATE	
		DRAWN: P. DO	7/2/2015	<b>4837-0B-XX</b> <b>200uL GEL TIP-LONG TIP (FLATTENED)</b>
SSI MATERIAL:		CHECKED:		
MANUFACTURER'S MATERIAL:		RESP ENG:		
FINISH:		MFG ENG:		SIZE: SHRINK RATE:
DO NOT SCALE DRAWING		QUAL ENG:		A
		SCALE: 1:1		REV.: REL
		JOB NO.:		SHEET: 1 OF 1

PRINTED 3/18/2016