


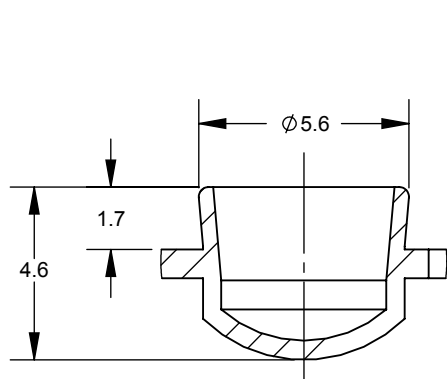


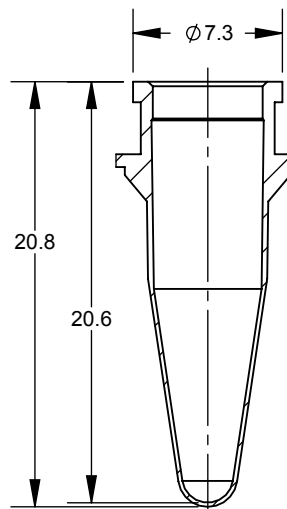

DETAIL B
SCALE: 5 : 1
TYP

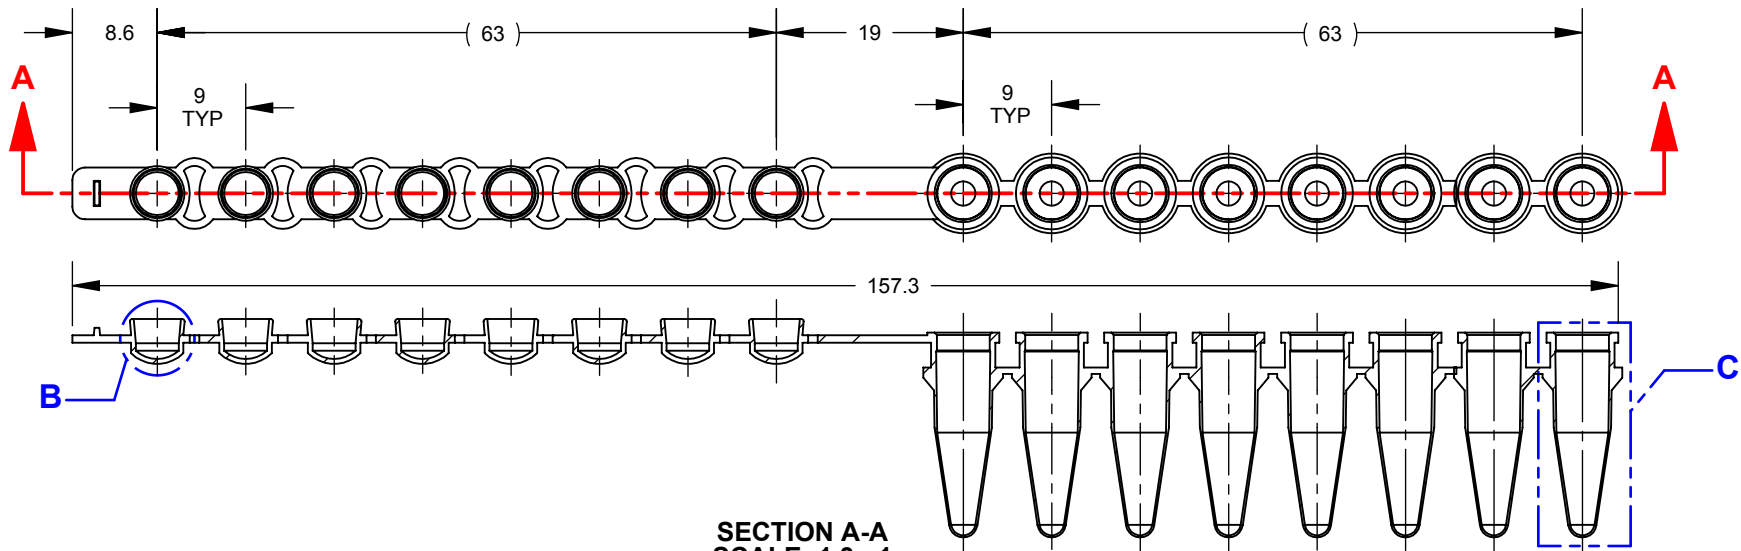

DETAIL C
SCALE: 2.7 : 1
TYP

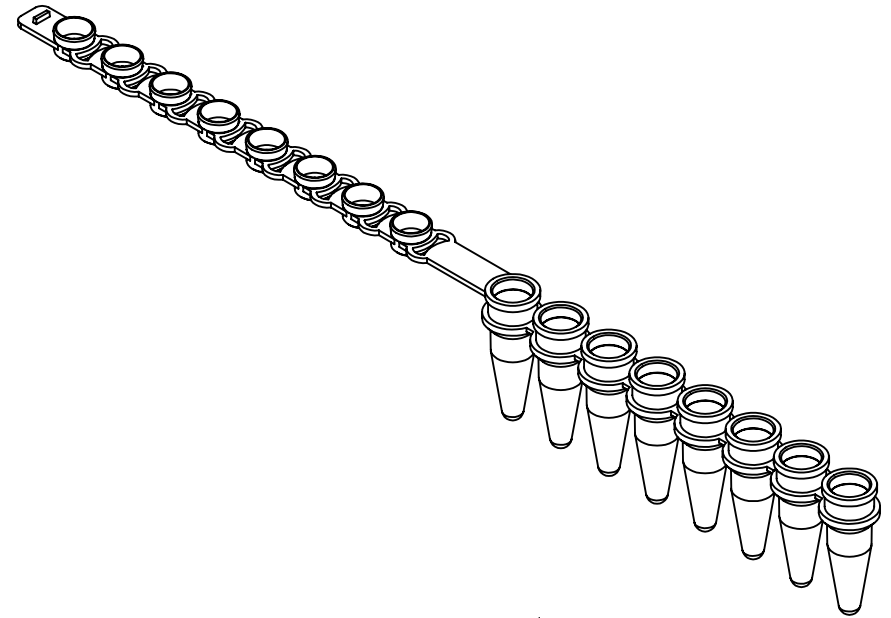

SECTION A-A
SCALE: 1.3 : 1

UNLESS OTHERWISE SPECIFIED
DIMENSIONS ARE IN MILLIMETERS

CAD GENERATED DRAWING,
DO NOT MANUALLY UPDATE



1310 Thurman Street
Lodi CA, 95240
Ph: (209) 333-2120
Fx: (209) 333-8623
info@scientificspecialties.com

	APPROVALS		DATE
	DRAWN:	CHECKED:	
SSI MATERIAL:	P. DO		1/25/2018
MANUFACTURER'S MATERIAL:	DESIGN ENG:		
FINISH:	MFG ENG:		
DO NOT SCALE DRAWING	QUAL ENG:		

3230-XX		
8-STRIP TUBE WITH ATTACHED CAP		
PRODUCTION MOLD ID# 1		
SIZE: A	SHRINK RATE:	REV.: 1
SCALE: 1:1	JOB NO.:	SHEET: 1 OF 1

PRINTED 1/25/2018