

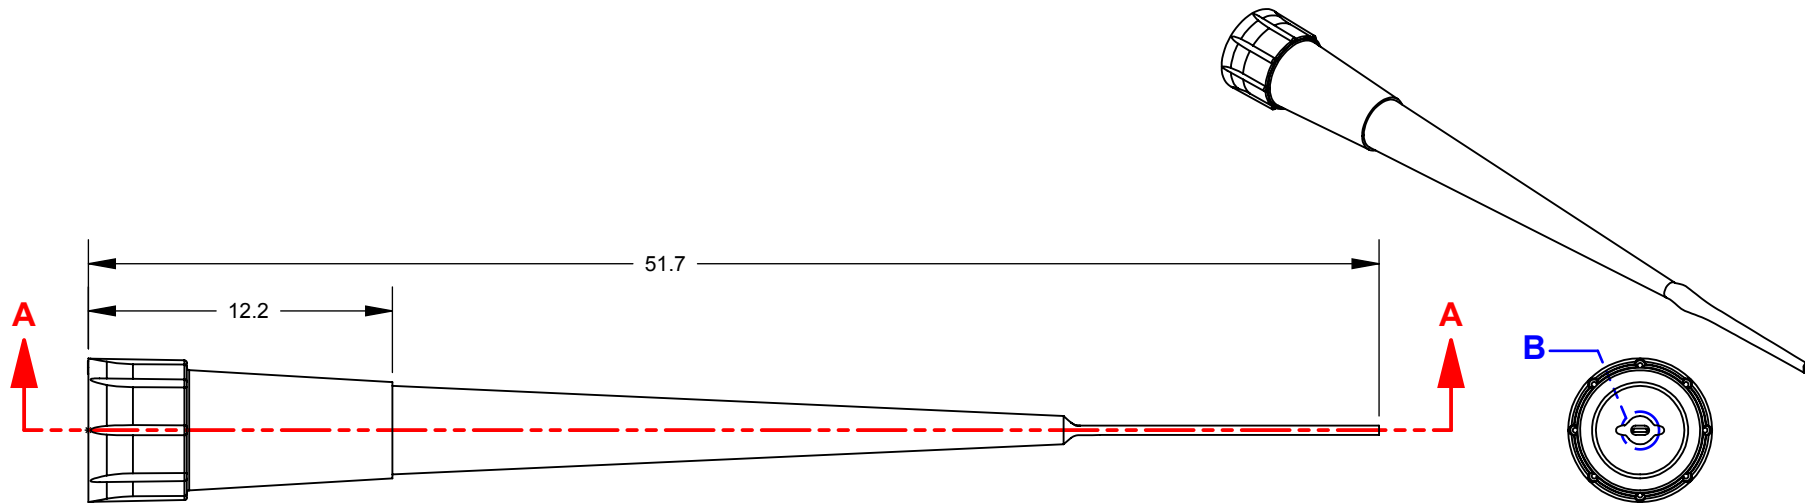


SECTION A-A

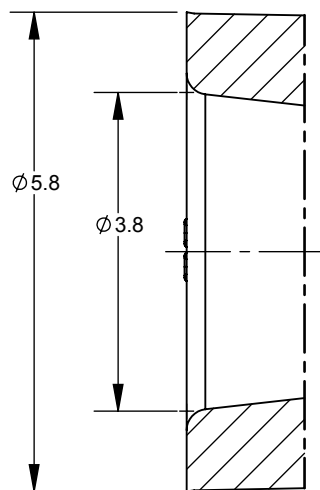

DETAIL C

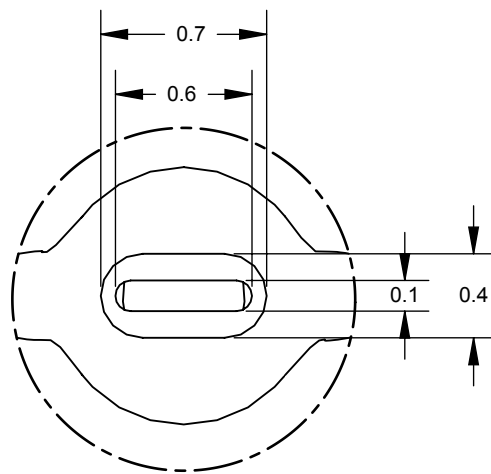

DETAIL B

UNLESS OTHERWISE SPECIFIED
DIMENSIONS ARE IN MILLIMETERS

CAD GENERATED DRAWING,
DO NOT MANUALLY UPDATE

APPROVALS	DATE
DRAWN: P. DO	10/20/2016
CHECKED:	

SSI MATERIAL:

MANUFACTURER'S MATERIAL:

FINISH:

DO NOT SCALE DRAWING

DESIGN ENG:

MFG ENG:

QUAL ENG:



1310 Thurman Street
Lodi CA, 95240
Ph: (209) 333-2120
Fax: (209) 333-8623
info@scientificspecialties.com

4817-0A-XX

10µL FLATTEN GEL TIP-SHORT

SIZE: SHRINK RATE:

A

SCALE: 1:1

JOB NO.:

REV.:
REL

SHEET: 1 OF 1

PRINTED 10/20/2016