

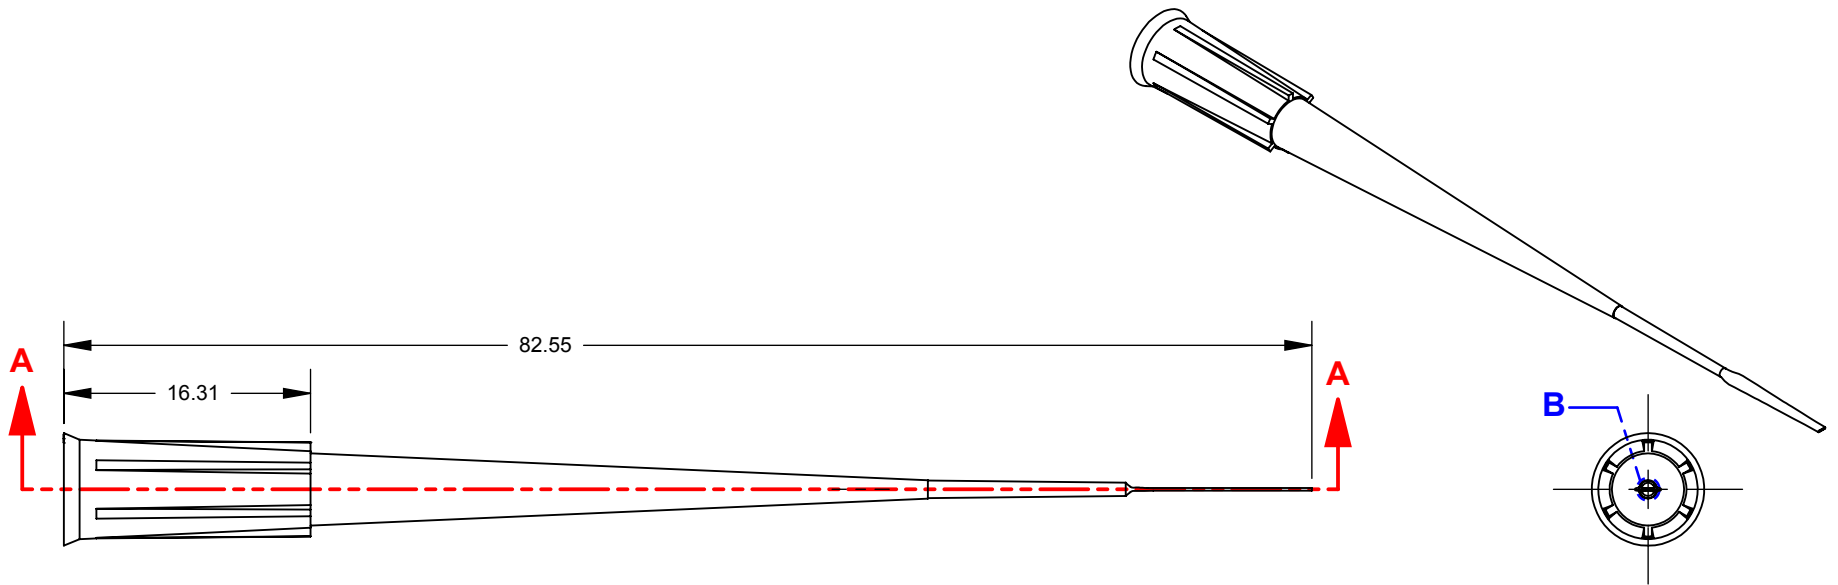


SECTION A-A
SCALE: 2 : 1

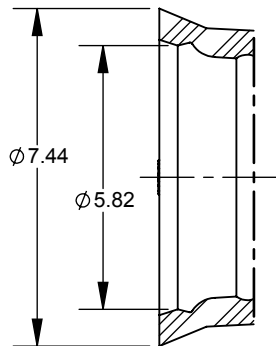

DETAIL C
SCALE: 6 : 1

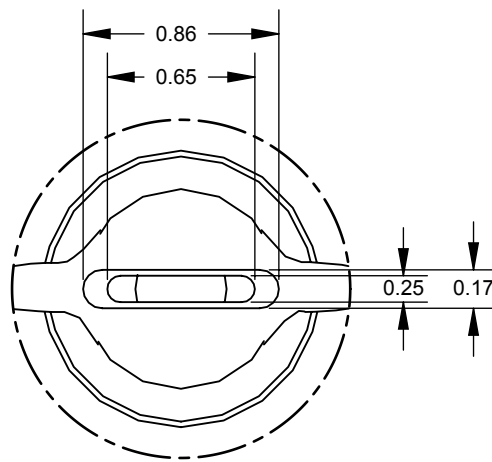

DETAIL B
SCALE: 30 : 1

UNLESS OTHERWISE SPECIFIED
DIMENSIONS ARE IN MILLIMETERS

CAD GENERATED DRAWING,
DO NOT MANUALLY UPDATE

APPROVALS	DATE
DRAWN: P. DO	6/27/2016
CHECKED:	

SSI MATERIAL:

DESIGN ENG:

MANUFACTURER'S MATERIAL:

MFG ENG:

FINISH:

QUAL ENG:

DO NOT SCALE DRAWING



1310 Thurman Street
Lodi CA, 95240
Ph: (209) 333-2120
Fx: (209) 333-8623
info@scientificspecialties.com

4837-0B-XX
200µL FLATTEN GEL TIP-LONG

SIZE: **A** SHRINK RATE:

SCALE: 1:1

JOB NO.:

REV.:
REL

SHEET: 1 OF 1

PRINTED 6/27/2016